
 


ALL BEDS ARE SHOWN AS QUEEN SIZE UNLESS OTHERWISE NOTED.

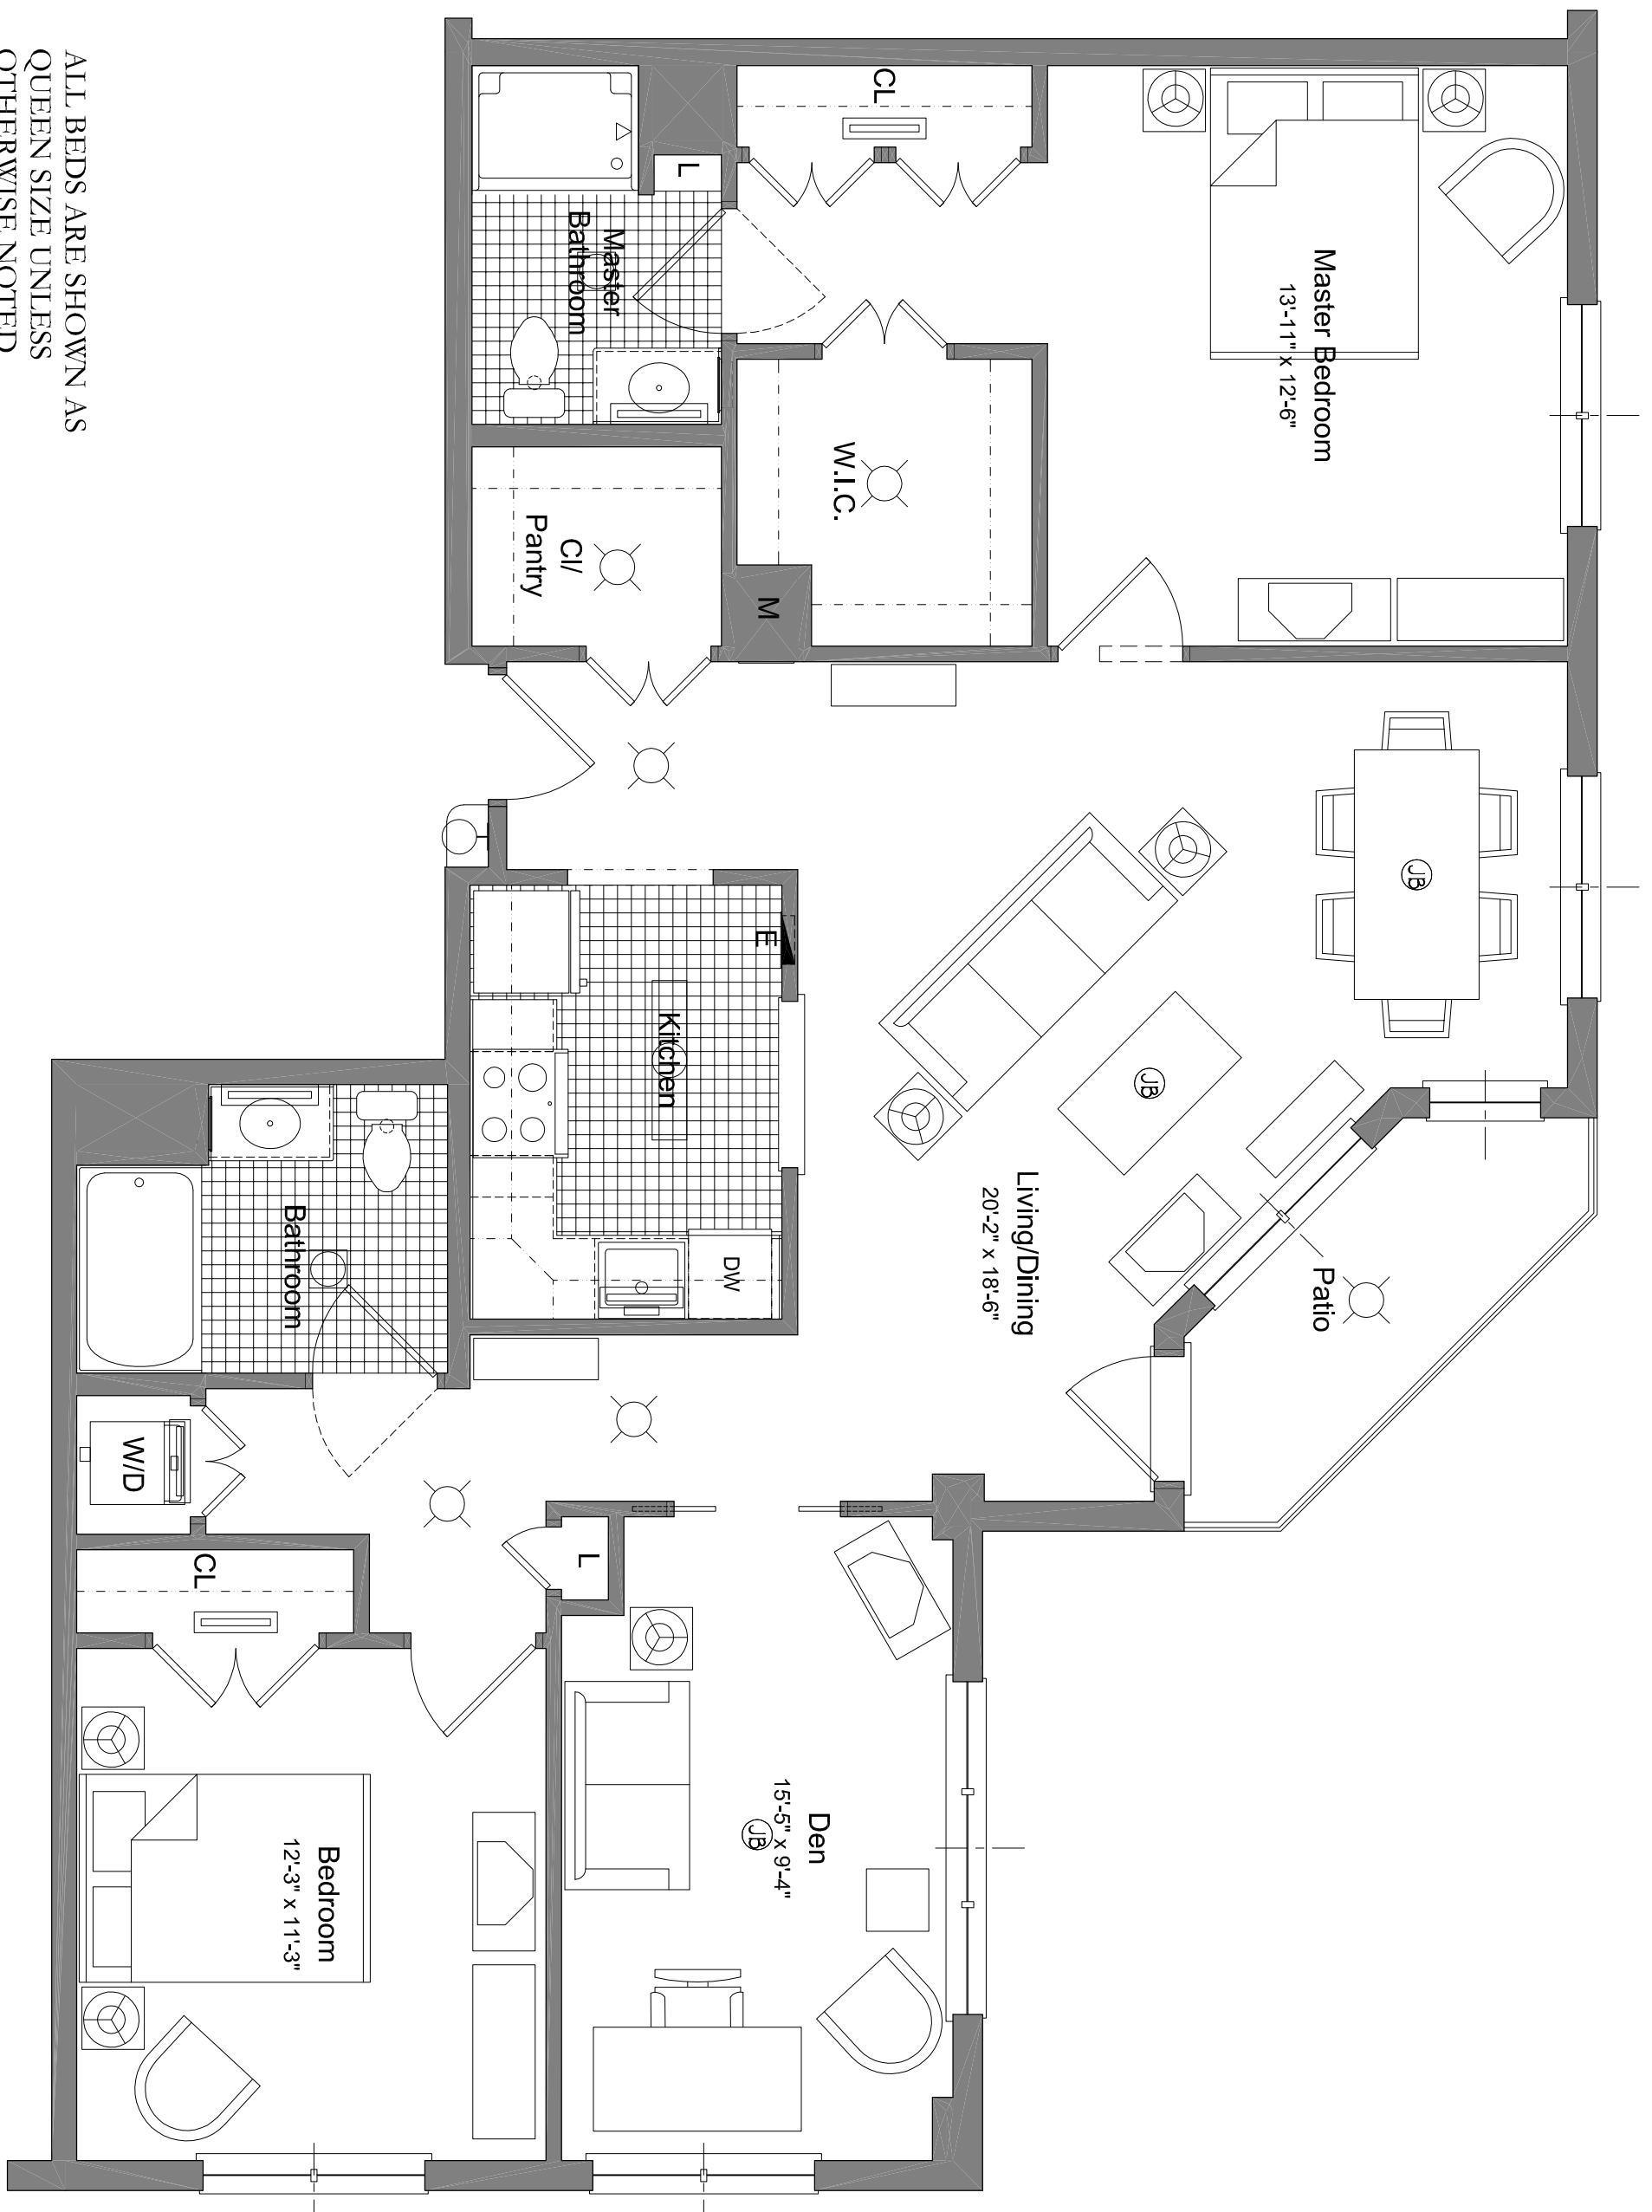

Monument - Two Bedroom with Den



Scale: 1/4" = 1'-0"

1,376 SQ. FT.
Unit Number: 226, 326, 426

Actual unit S.F and configuration may differ due to structural and/or mechanical layout changes during construction.